
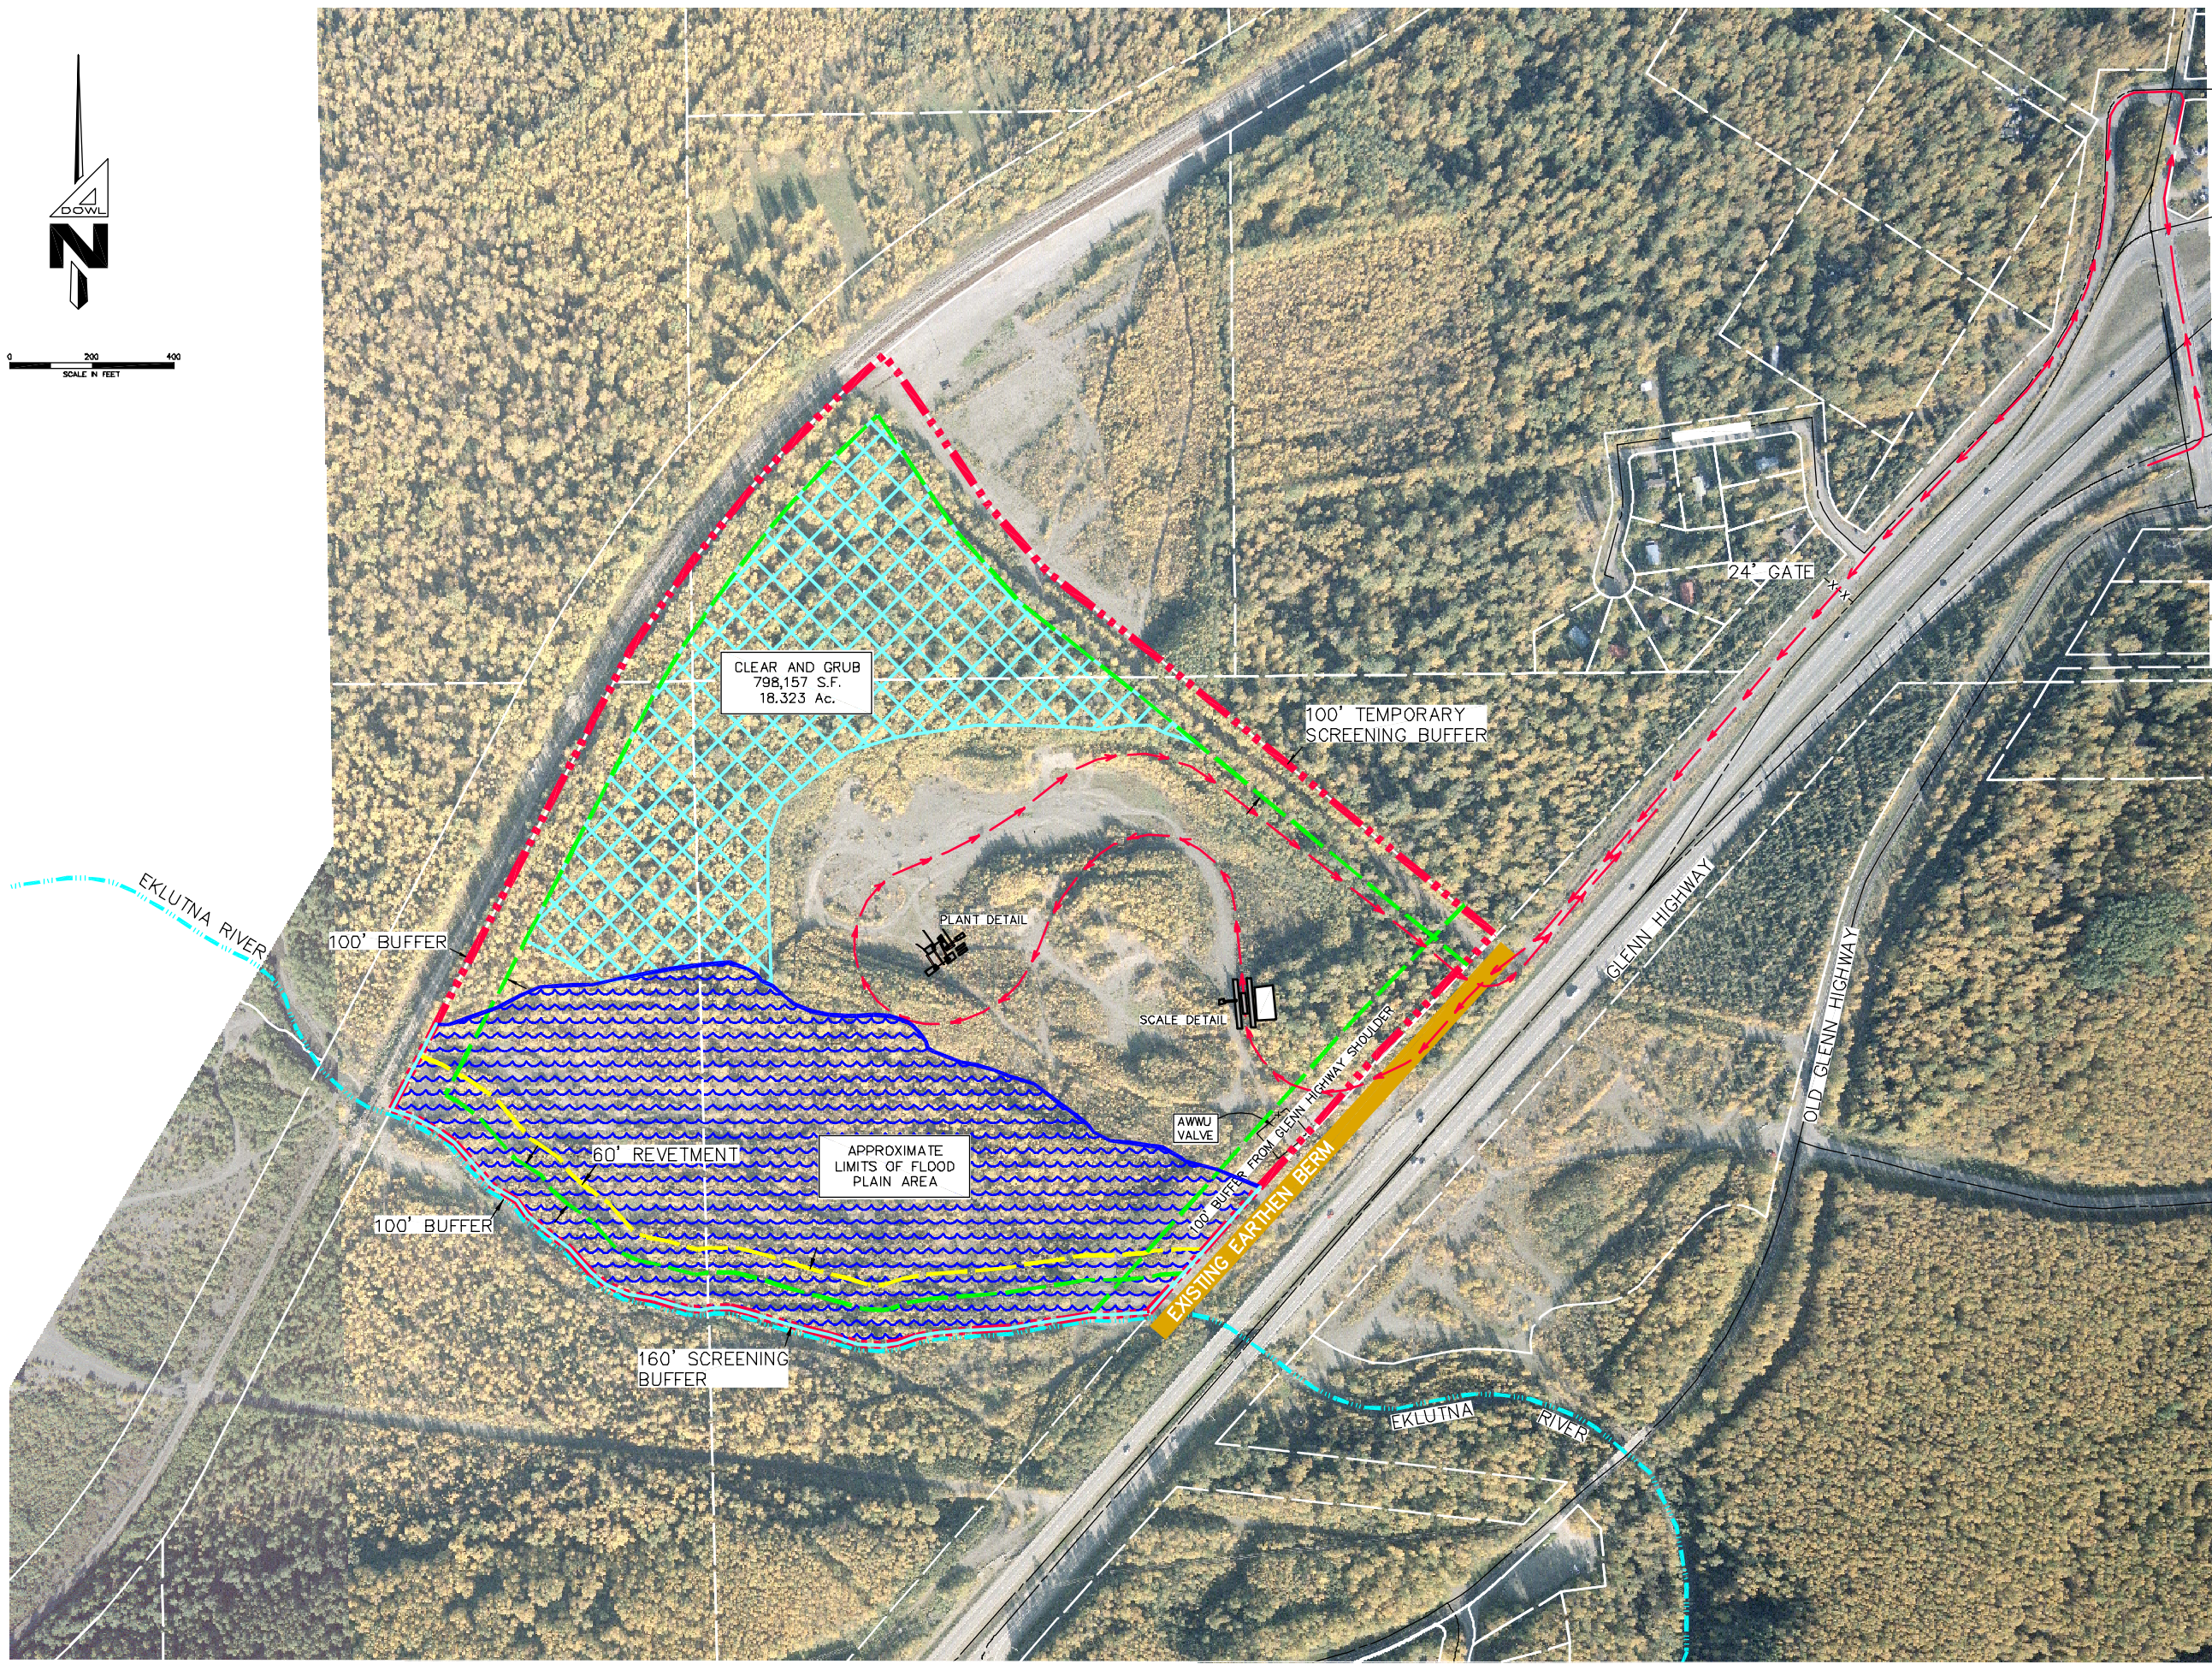


PROJECT: P:\PROJECTS\058475\PLANNING DRAWING NAME: DCP-AAP SITE.DWG SCRIPT FILE FOR THIS SHEET: PLOTTED: APR 06 2007 15:11:52 (BFARRELL) DOWL FILE No:

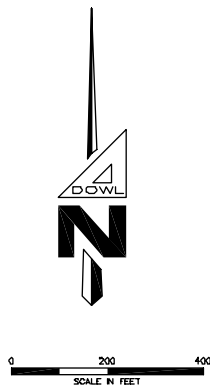

DATA	BY
Storm Sewer	
Water	
Gas	
Telephone	
Electric	
Cable TV	
Existing Eln.	
Approved	

DOWL ENGINEERS
 Anchorage, Alaska 99503
 4041 "B" Street
 PHONE (907) 562-2000
 FAX (907) 563-3863

**SITE PLAN
 AAP EKLUTNA
 NATURAL RESOURCE EXTRACTION**
 SITE 1 - PHASE 1

CHECKED BY	
DESIGNED BY	
DRAWN BY	BKF
DATE	04/06/07
W.O. NO.	059475
F.B. NO.	
REF. DWG	
LOCATION	

SCALE	
HORZ.	1" = 200'
VERT.	(22" x 34")

SHEET
Figure 1
 FILE NO. *